

MEDITECH

EXECUTIVE CENTER
200 LOWDER BROOK DR., WESTWOOD, MA 02090



 






DESIGNERS:
MEDITECH WALTHAM
21 HICKORY DRIVE, WALTHAM, MA 02451
TEL: 781-821-3000

LOWDER BROOK BLDG 200
3RD FLOOR


GENERAL NOTES:

- 1.
- 2.
- 3.
- 4.
- 5.
- 6.

LEGEND


-  NEW 2' x 4' LIGHT FIXTURE
-  NEW 2' x 2' LIGHT FIXTURE
-  NEW 4' x 4' WALL WASHER
-  SUPPLY AIR
-  SUPPLY AIR
-  SMOKE DETECTOR
-  SPEAKER
-  SPRINKLER HEAD
-  EXIT SIGN

- SPL:
1. DO WE WANT TO CREATE SOFFITS @ NEW TEAM ROOM & OFFICES TO HAVE IT CONSISTENT WITH THE EXISTING ROOMS?
 2. DO WE WANT TO SUGGEST LOCATION OF HVAC ITEMS @ NEW TEAM ROOM & OFFICES?
 3. DO WE WANT TO REPLACE OR GET RID OF EXISTING WALL SCONCES @ WORKSTATION COLUMNS?
 4. 4' x 4' RECESSED DOWNLIGHT @ NEW PRINT STATIONS?
 4. SOME EXISTING OFFICES HAVE 2x2 LIGHT FIXTURES - KEEP THEM AS 2x2?
 5. NEW SMOKE DETECTOR, SPEAKER, EXIT SIGN?
 6. RELOCATE SPRINKLER AS NEEDED?
 7. SUPPLY/RETURN AIR SCOPE?
 8. NOT ALL EXISTING OFFICES HAVE SUPPLY/RETURN AIR-- DT TO VERIFY

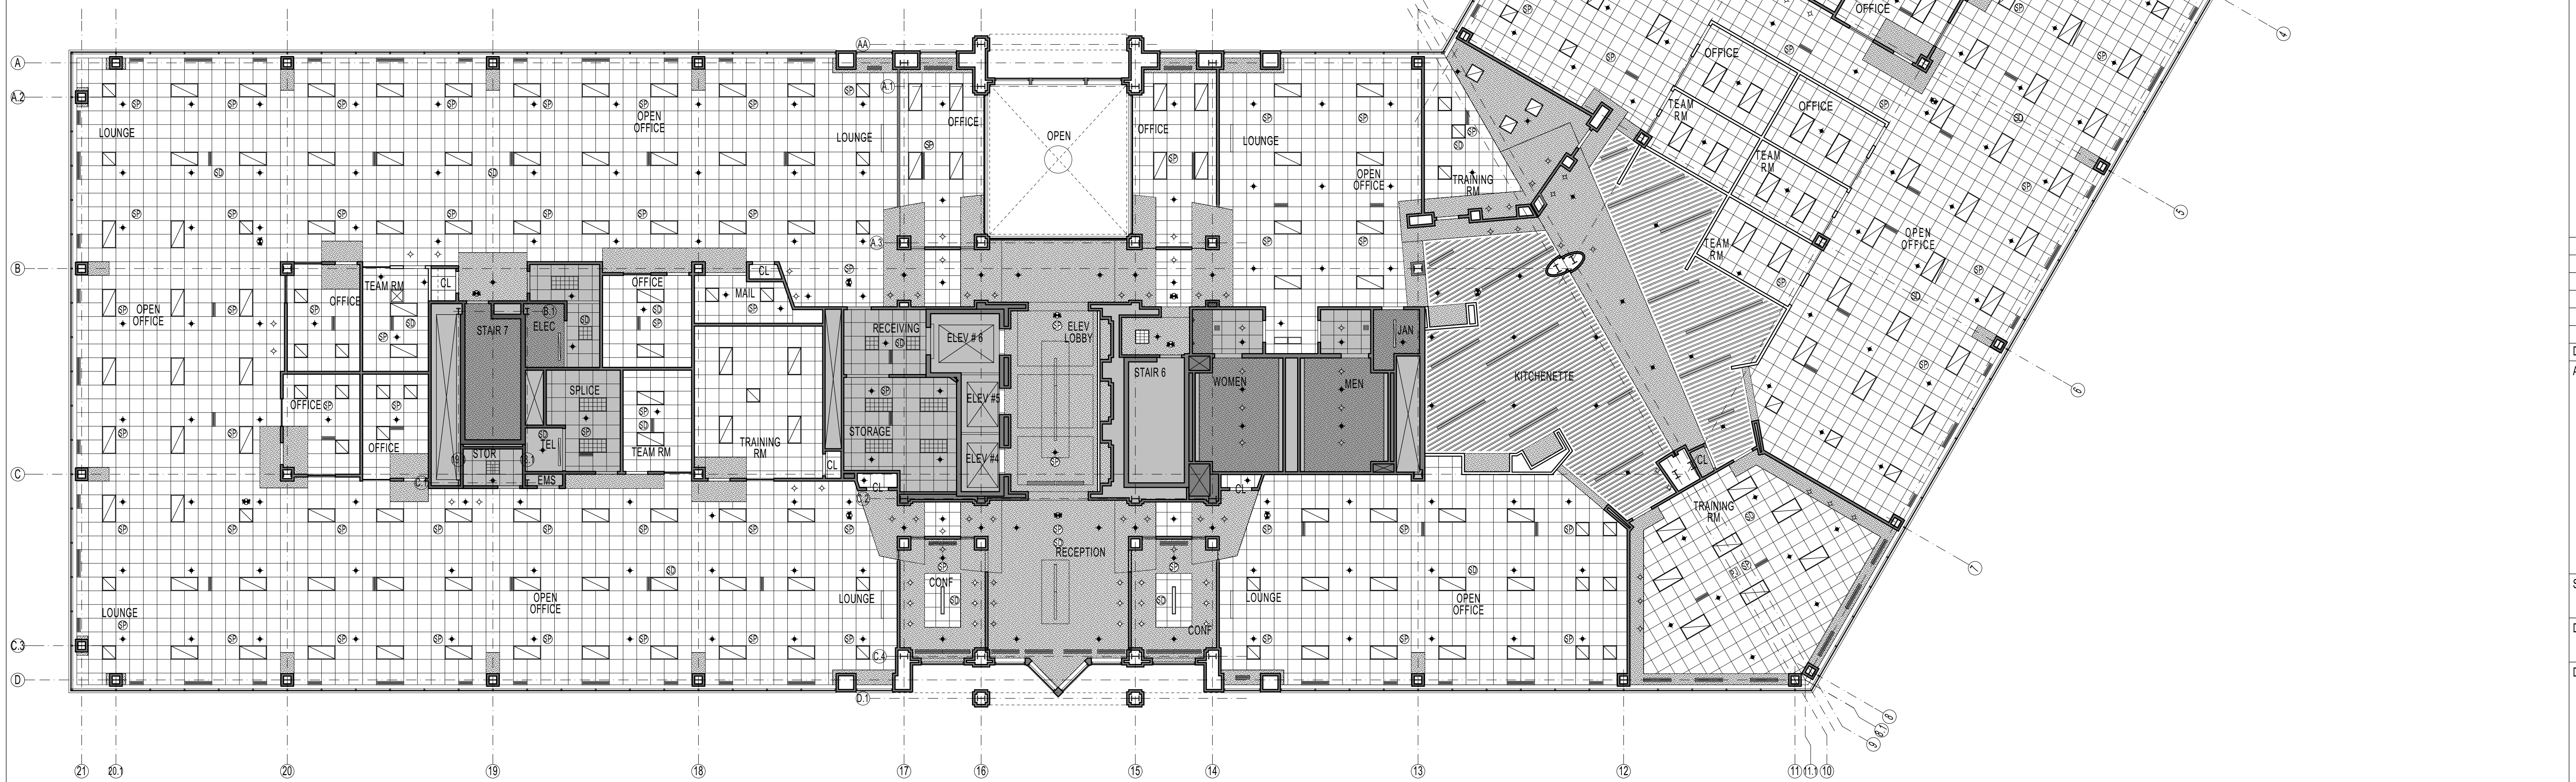

DATE DESCRIPTION

AREA OF WORK:

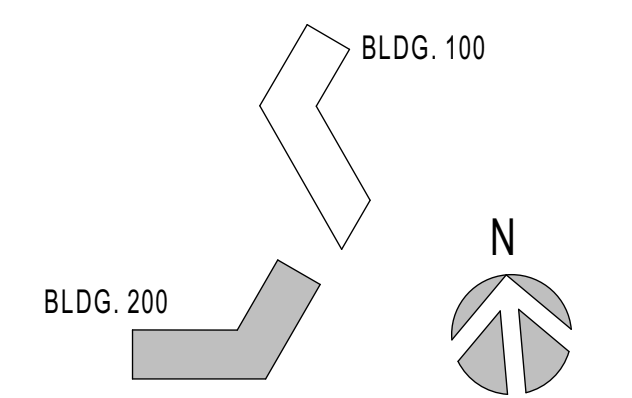

SCALE: AS NOTED

DATE ISSUED: 9/2019 PENDING

DRAWING NAME:

**PROPOSED
REFLECTED CEILING PLAN**

DRAWING NO:

MT 1.4